



FRONT ELEVATION

SCALE 1/4"=1'-0"

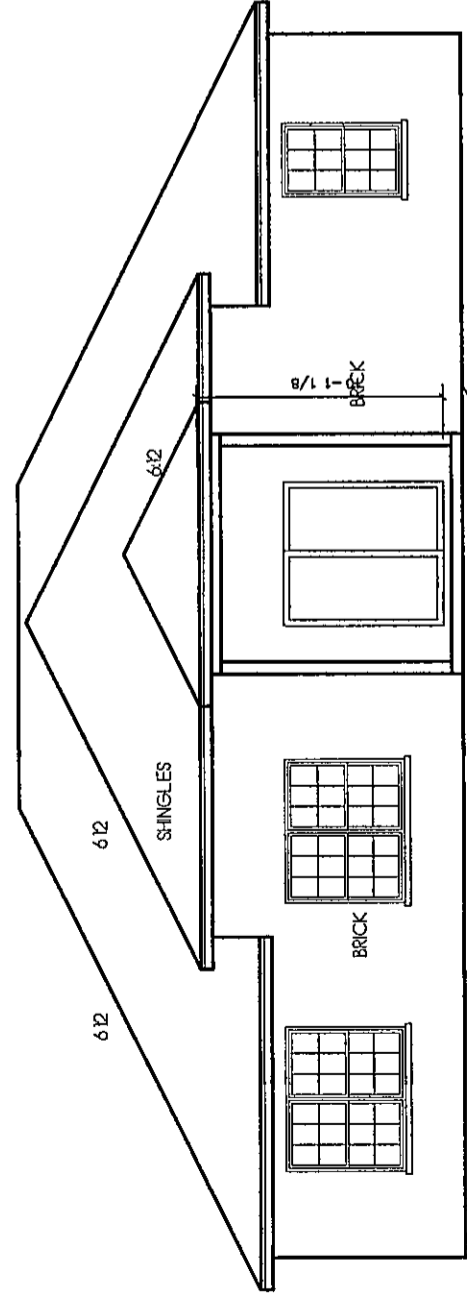


REAR ELEVATION

SCALE 1/8"=1'-0"

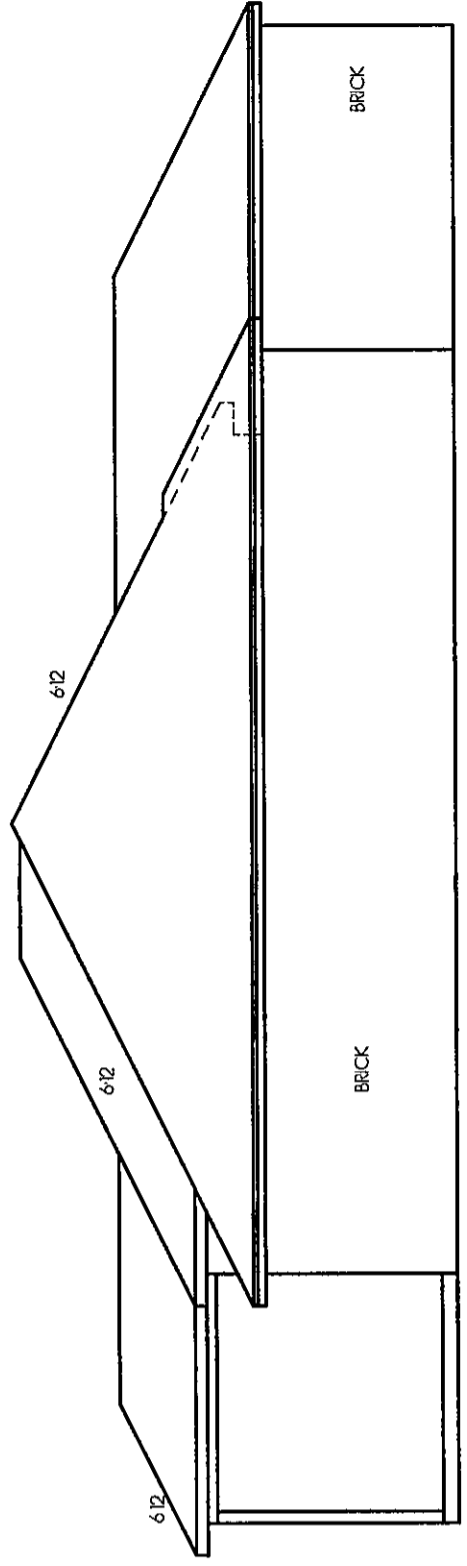

LEFT ELEVATION

SCALE 1/8"=1'-0"

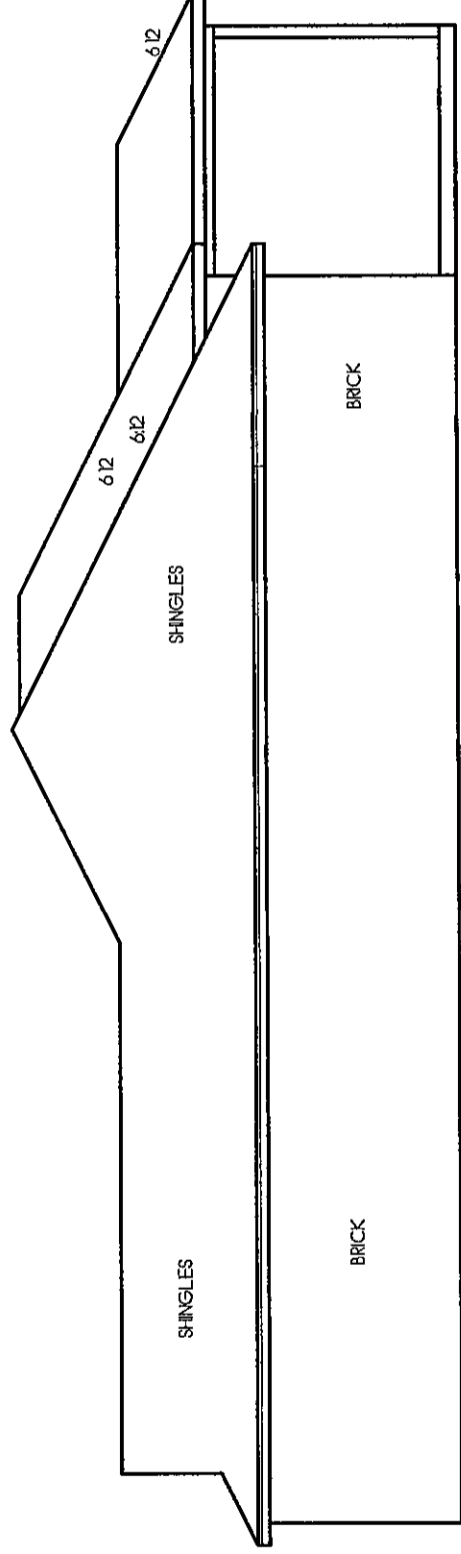

RIGHT ELEVATION

SCALE 1/8"=1'-0"

THESE PLANS AND THE IDEAS AND DIGITAL INFORMATION ARE THE PROPERTY OF GULF COAST ENGINEERING AND ROLAND GODWIN DRAFTING ARE NOT TO BE REPRODUCED, COPIED, IN ANY FORM OR MANNER WITHOUT THE EXPRESS WRITTEN PERMISSION OR CONSENT OF GULF COAST ENGINEERING OR ROLAND GODWIN DRAFTING

SHEET INDEX	
1.	ELEVATIONS
2.	FLOOR PLAN
3.	FLOOR PLAN
4.	ELECTRICAL PLAN
5.	ROOF PLAN
6.	STRUCTURAL
8-2	STRUCTURAL

CONTRACTOR / OWNER TO VERIFY ALL CONTENTS OF THIS PLAN

ROLAND GODWIN DRAFTING

(850) 862-6850

CONTRACTOR
EMERALD COAST CUSTOM HOMES, INC.
 850-499-9039 850-217-3112

2333 PRYTANIA CIRC
 SANTA ROSA COUNTY FLORIDA

PLAN NO.

Gulf Coast Engineering
 Commercial and Residential Design
 P.O. Box 4915
 1500 20th Street
 Ft. Myers, FL 33901
 MICHAEL NEWELL, PE or ELLIOTT ALLEN, PE
 FL REG. NO. 41122 FL REG. NO. 42131